

1325 S. Bumby Ave. Orlando, Florida 32806  
PH: (407) 896 7411 / FX: (407) 896 7412  
EMAIL: epgroup@att.net  
CA#8126  
FARSHAD ANTIKCHI, PE 72998

PROJECT NUMBER:  
MTF18144

# DME SPORTS HOUSING COMPLEX

OWNER/DEVELOPER: OWNER/REP: MIKE PANIAGO DIRECT MAIL EXPRESS, 244 BELLEVUE AVENUE, DAYTONA BEACH, FL 32114 (386) 271-3924  
PROJECT LOCATION: 2801 BELLEVUE AVENUE, DAYTONA BEACH, FL 32114  
GENERAL CONTRACTOR: BRIAN COLLIER, 375 FEETNESS BOULEVARD, DAYTONA BEACH, FL 32114, PH: (386) 576-7177

## BPF DESIGN INCORPORATED

ARCHITECTURE, DESIGN & DRAWING SERVICES  
# AA 2801108  
BRIAN P. FREDLEY, ASSOC. AIA, PROJECT MANAGER  
DALLAS B. PEACOCK, AIA, ARCHITECT  
# AR 0009706  
207 FAIRVIEW AVENUE, DAYTONA BEACH, FL 32114  
PH: (386) 257-6902 FX: (386) 257-1050  
E-MAIL: bpfdesign@cdlr.com WEBSITE: bpfdesign.net

### PLUMBING RISER DIAGRAM - SEWER

DATE: 05/13/2019


SCALE: AS SHOWN

SHT NO. P-5

ARCHITECT'S / ENGINEER'S SEAL

### Reference Notes

#	Number	Description
1	1	PIPING LOCATED AT OR ABOVE CEILING
2	2	PIPING LOCATED BELOW FLOOR SLAB

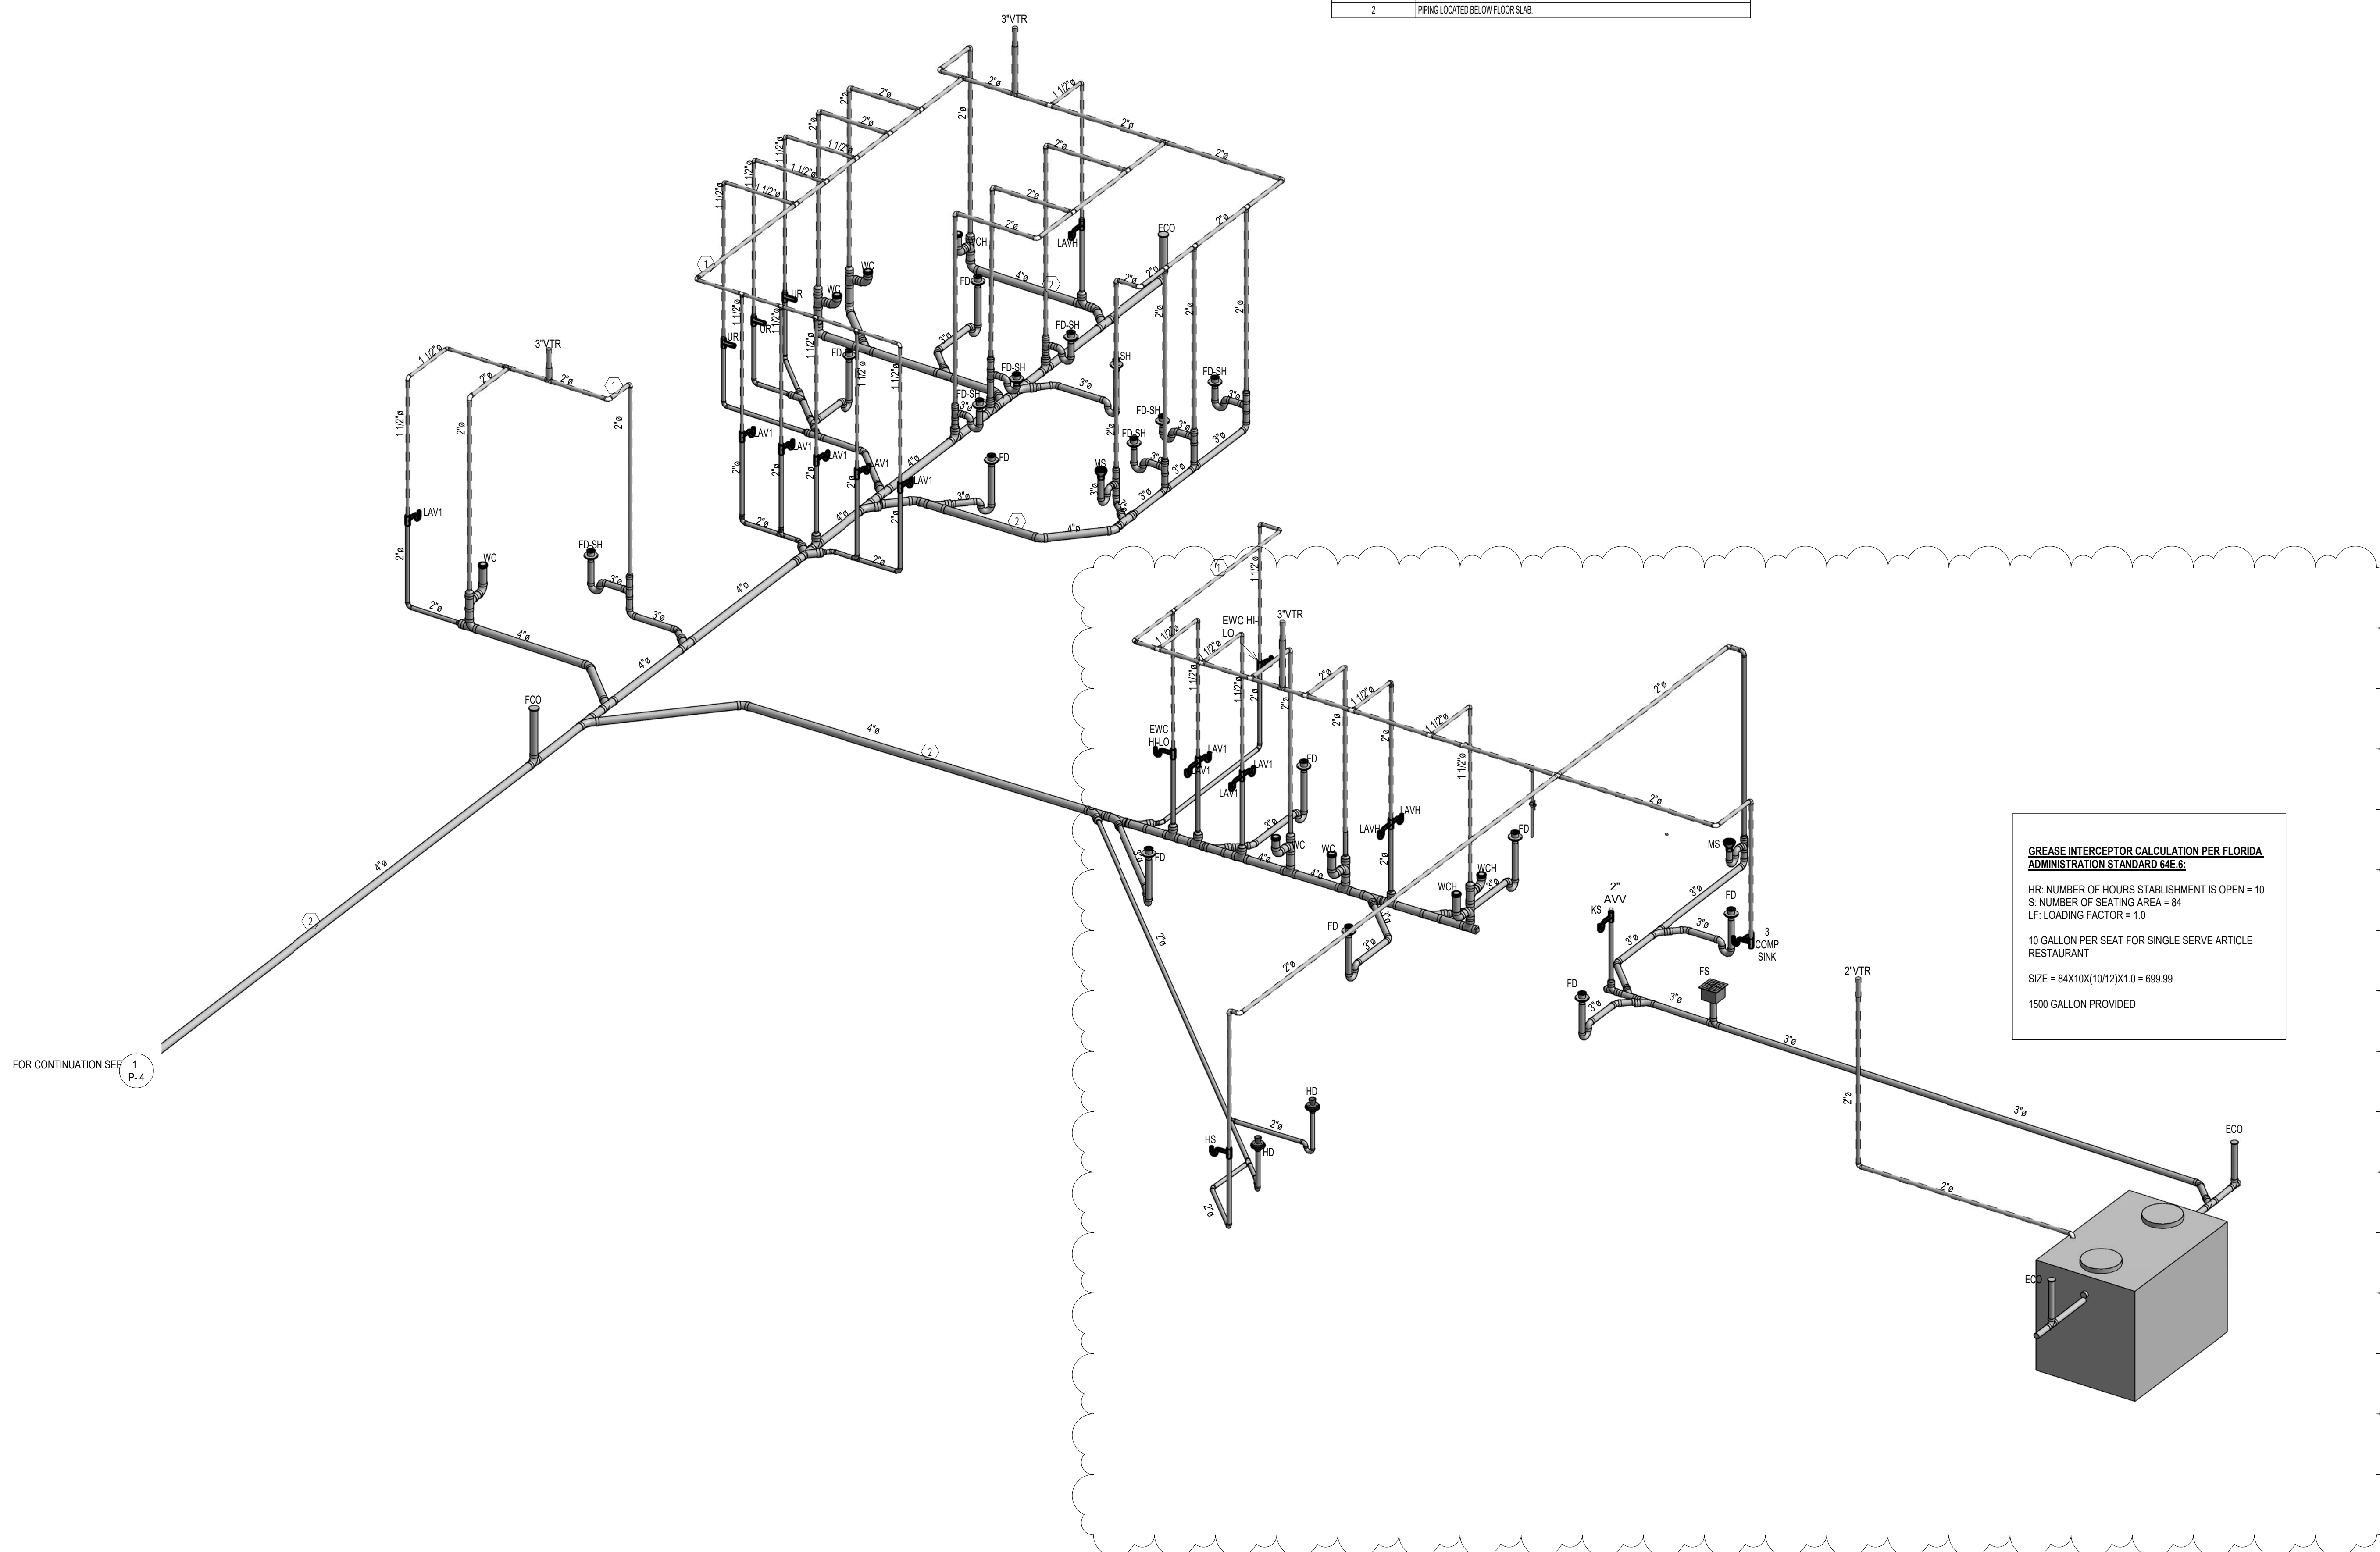

FOR CONTINUATION SEE 1 P-4