


#	REVISIONS
1	04/15/20 ADDENDUM #1



1325 S. Bumby Ave. Orlando, Florida 32806
 PH: (407) 896 7411 / FX: (407) 896 7412
 EMAIL: epgroup@att.net
 CA#8126
FARSHAD ANTIKCHI, PE 72998

PROJECT NUMBER:
MTF18144

Reference Notes	
#	Description
1	PIPING LOCATED AT OR ABOVE CEILING.
2	PIPING DROP AND RUN IN WALL.
3	PIPING LOCATED IN WALL AND RUN TO CONNECT TO FIXTURES.
4	PIPING LOCATED BELOW FLOOR SLAB.

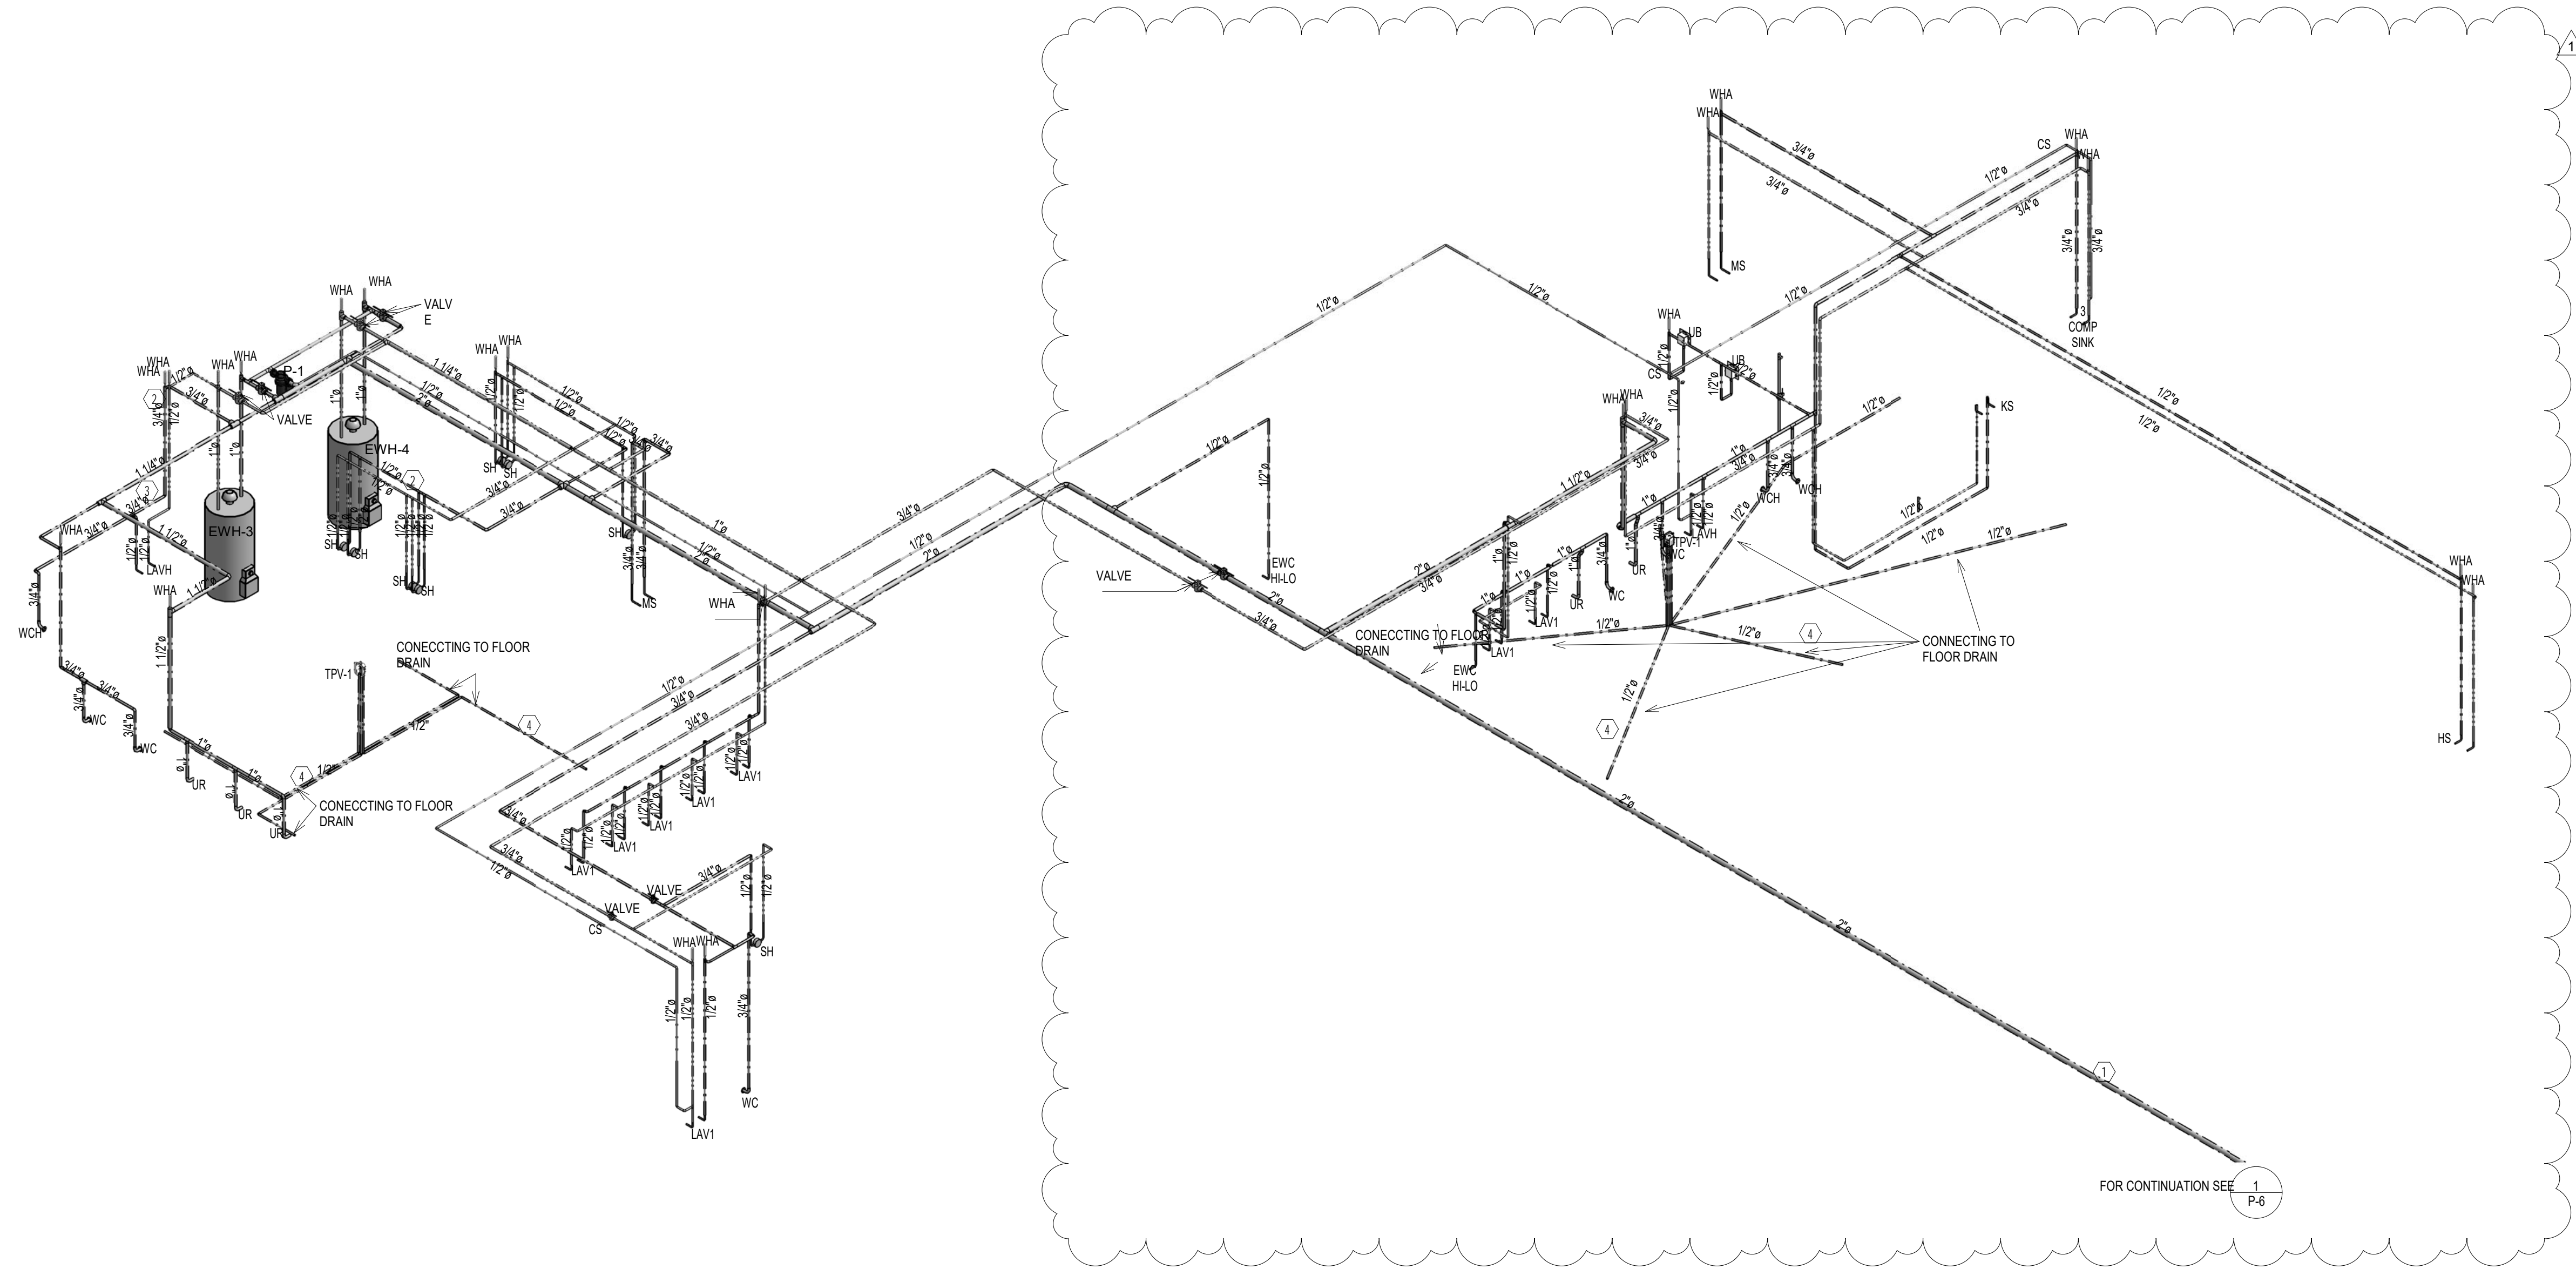

1 Plumbing Riser Diagram - Water
 P-6

DME SPORTS HOUSING COMPLEX

OWNER/DEVELOPER: OWNER/REP: MIKE PANAGGIO DIRECT MAIL EXPRESS, 244 BELLEVUE AVENUE, DAYTONA BEACH, FL 32114 (888) 271-3924
 PROJECT LOCATION: 2801 BELLEVUE AVENUE, DAYTONA BEACH, FL 32114
 GENERAL CONTRACTOR: BRIAN COLLIER, 315 FEINTESS BOULEVARD, DAYTONA BEACH, FL 32114, PH: (386) 576-7177

BPF
 DESIGN INCORPORATED
 ARCHITECTURE, DESIGN & DRAWING SERVICES
 # AA 2801108
 BRIAN P. FREDLEY, ASSOC. AIA, PROJECT MANAGER
 DALLAS B. PEACOCK, AIA, ARCHITECT
 # AR 0009706
 207 FAIRVIEW AVENUE, DAYTONA BEACH, FL 32114
 PH: (386) 257-6902 FX: (386) 257-1050
 E-MAIL: bpfdesign@cdi.ir.com WEBSITE: bpfdesign.net

PLUMBING RISER DIAGRAM - WATER

DATE: 05/13/2019
 SCALE: AS SHOWN

SHT NO. P-6

ARCHITECT'S / ENGINEER'S SEAL