


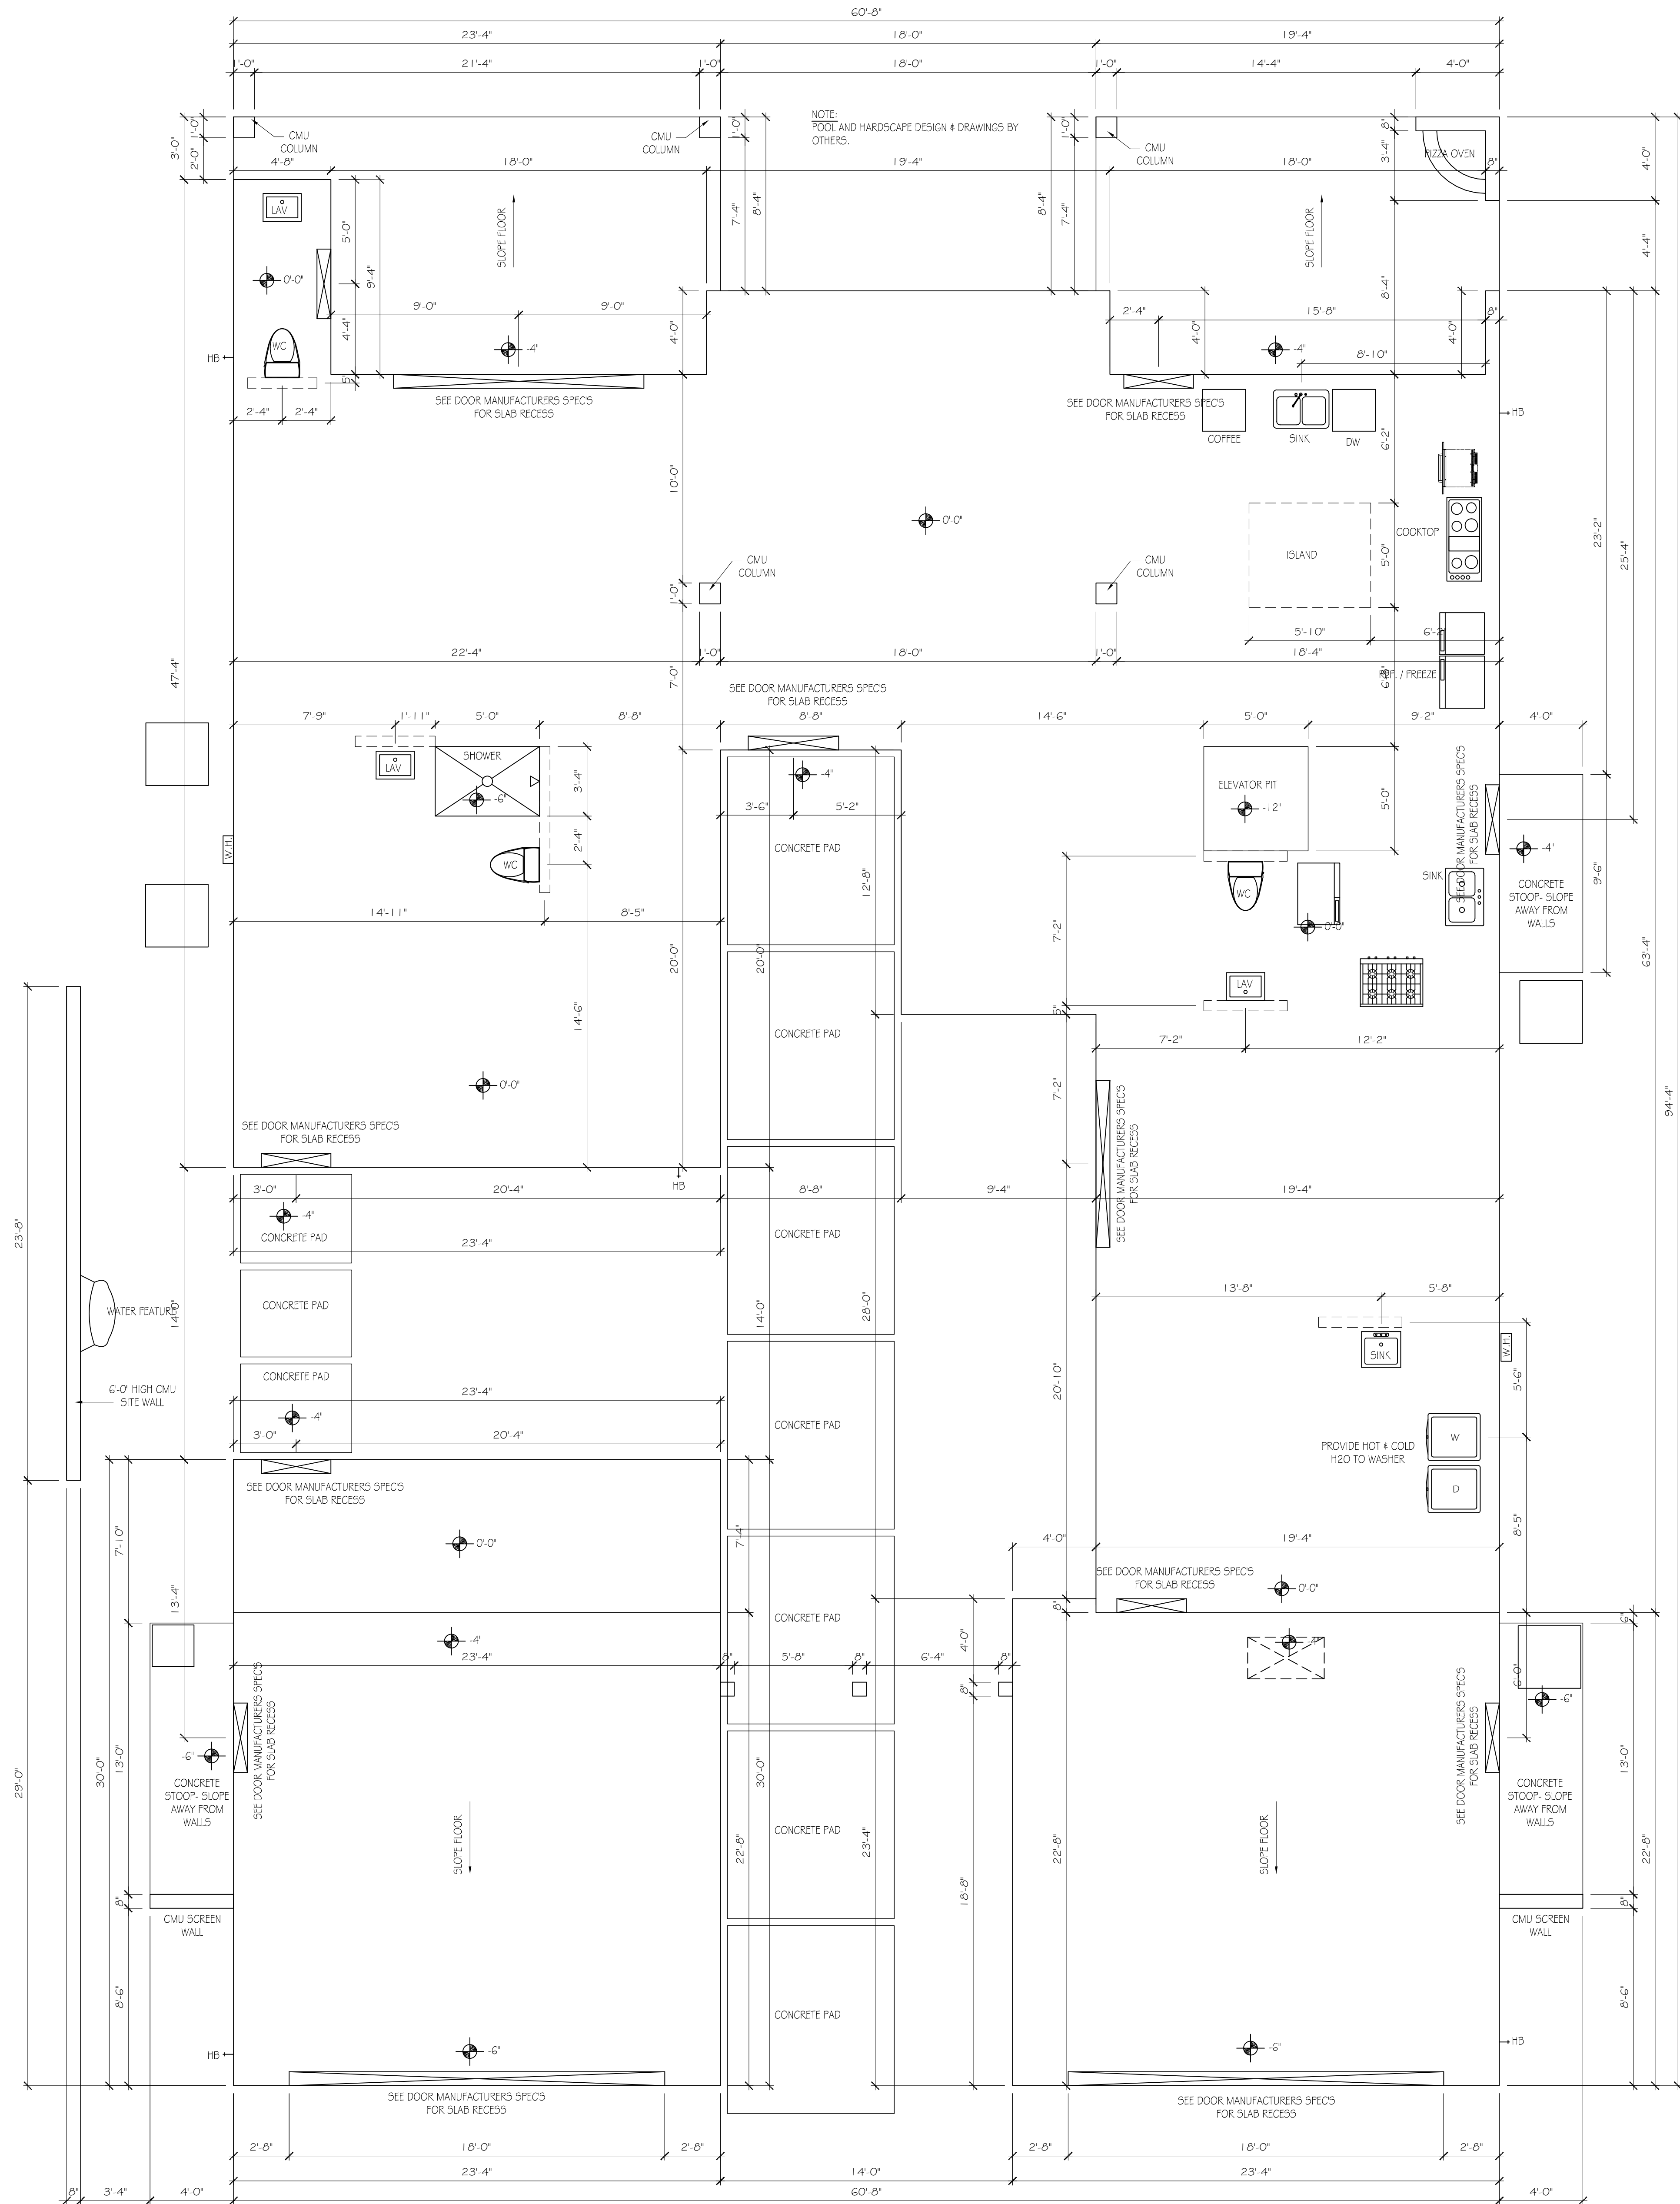

SLAB / PLUMBING PLAN

SCALE: 1/4" = 1'-0"

City of Ormond Beach
REVIEWED FOR
CODE COMPLIANCE

*This does not grant permission to violate any applicable law, code or ordinance.

BP19-00003561

Stamped By: Roxanne Deknatel

07/17/19 04:43 PM

REVISIONS	BY
1. Initial Design	EL
2. Structural	EL
3. Electrical	EL
4. Mechanical	EL
5. Final	EL

A B D
N.C.B.D.C.
JAMES C. LUCIA
RESIDENTIAL DESIGN
j.lucia@lucidesigns.com

Lucia

CUSTOM DESIGN FOR THE:
DESAI RESIDENCE
380 RIVERSIDE DRIVE
ORMOND BEACH, FL 32176

DATE: 03-26-2019
SCALE: NOTED
DRAWN: EML
JOB:
SHEET
2
OF SHEETS