


EMBRY-RIDDLE AERONAUTICAL UNIVERSITY NEW PRINT SHOP BUILDING

DAYTONA BEACH, FL CAMPUS

SALAS O'BRIEN
[... expect a difference ...]
3501 Quadrangle Boulevard, Suite 100
Orlando, Florida 32817
(407) 390-0400
CERT. OF AUTH. NO. 6106
GARY A. WILKERSON, P.E. 43167
KYLE J. CARTER, P.E. 63069
JEFF A. KIRKMAN, P.E. 65529
ADAM S. LEVINE, P.E. 77010
19005


HOUSEMAN ARCHITECTURE
931 S SEMORAN BLVD #204B WINTER PARK, FL 32782
4091745
ALL IDEAS, DESIGNS, AND DETAILS REPRESENTED BY THIS DRAWING ARE OWNED BY AND THE PROPERTY OF HOUSEMAN ARCHITECTURE, LLC. NO REUSE, REPRODUCTION, COPIING, OR DEVELOPMENT FOR USE ON OR IN CONNECTION WITH THE SPECIFIED PROJECT, NOW OR IN THE FUTURE, IS PERMITTED WITHOUT THE WRITTEN PERMISSION OF HOUSEMAN ARCHITECTURE, LLC.

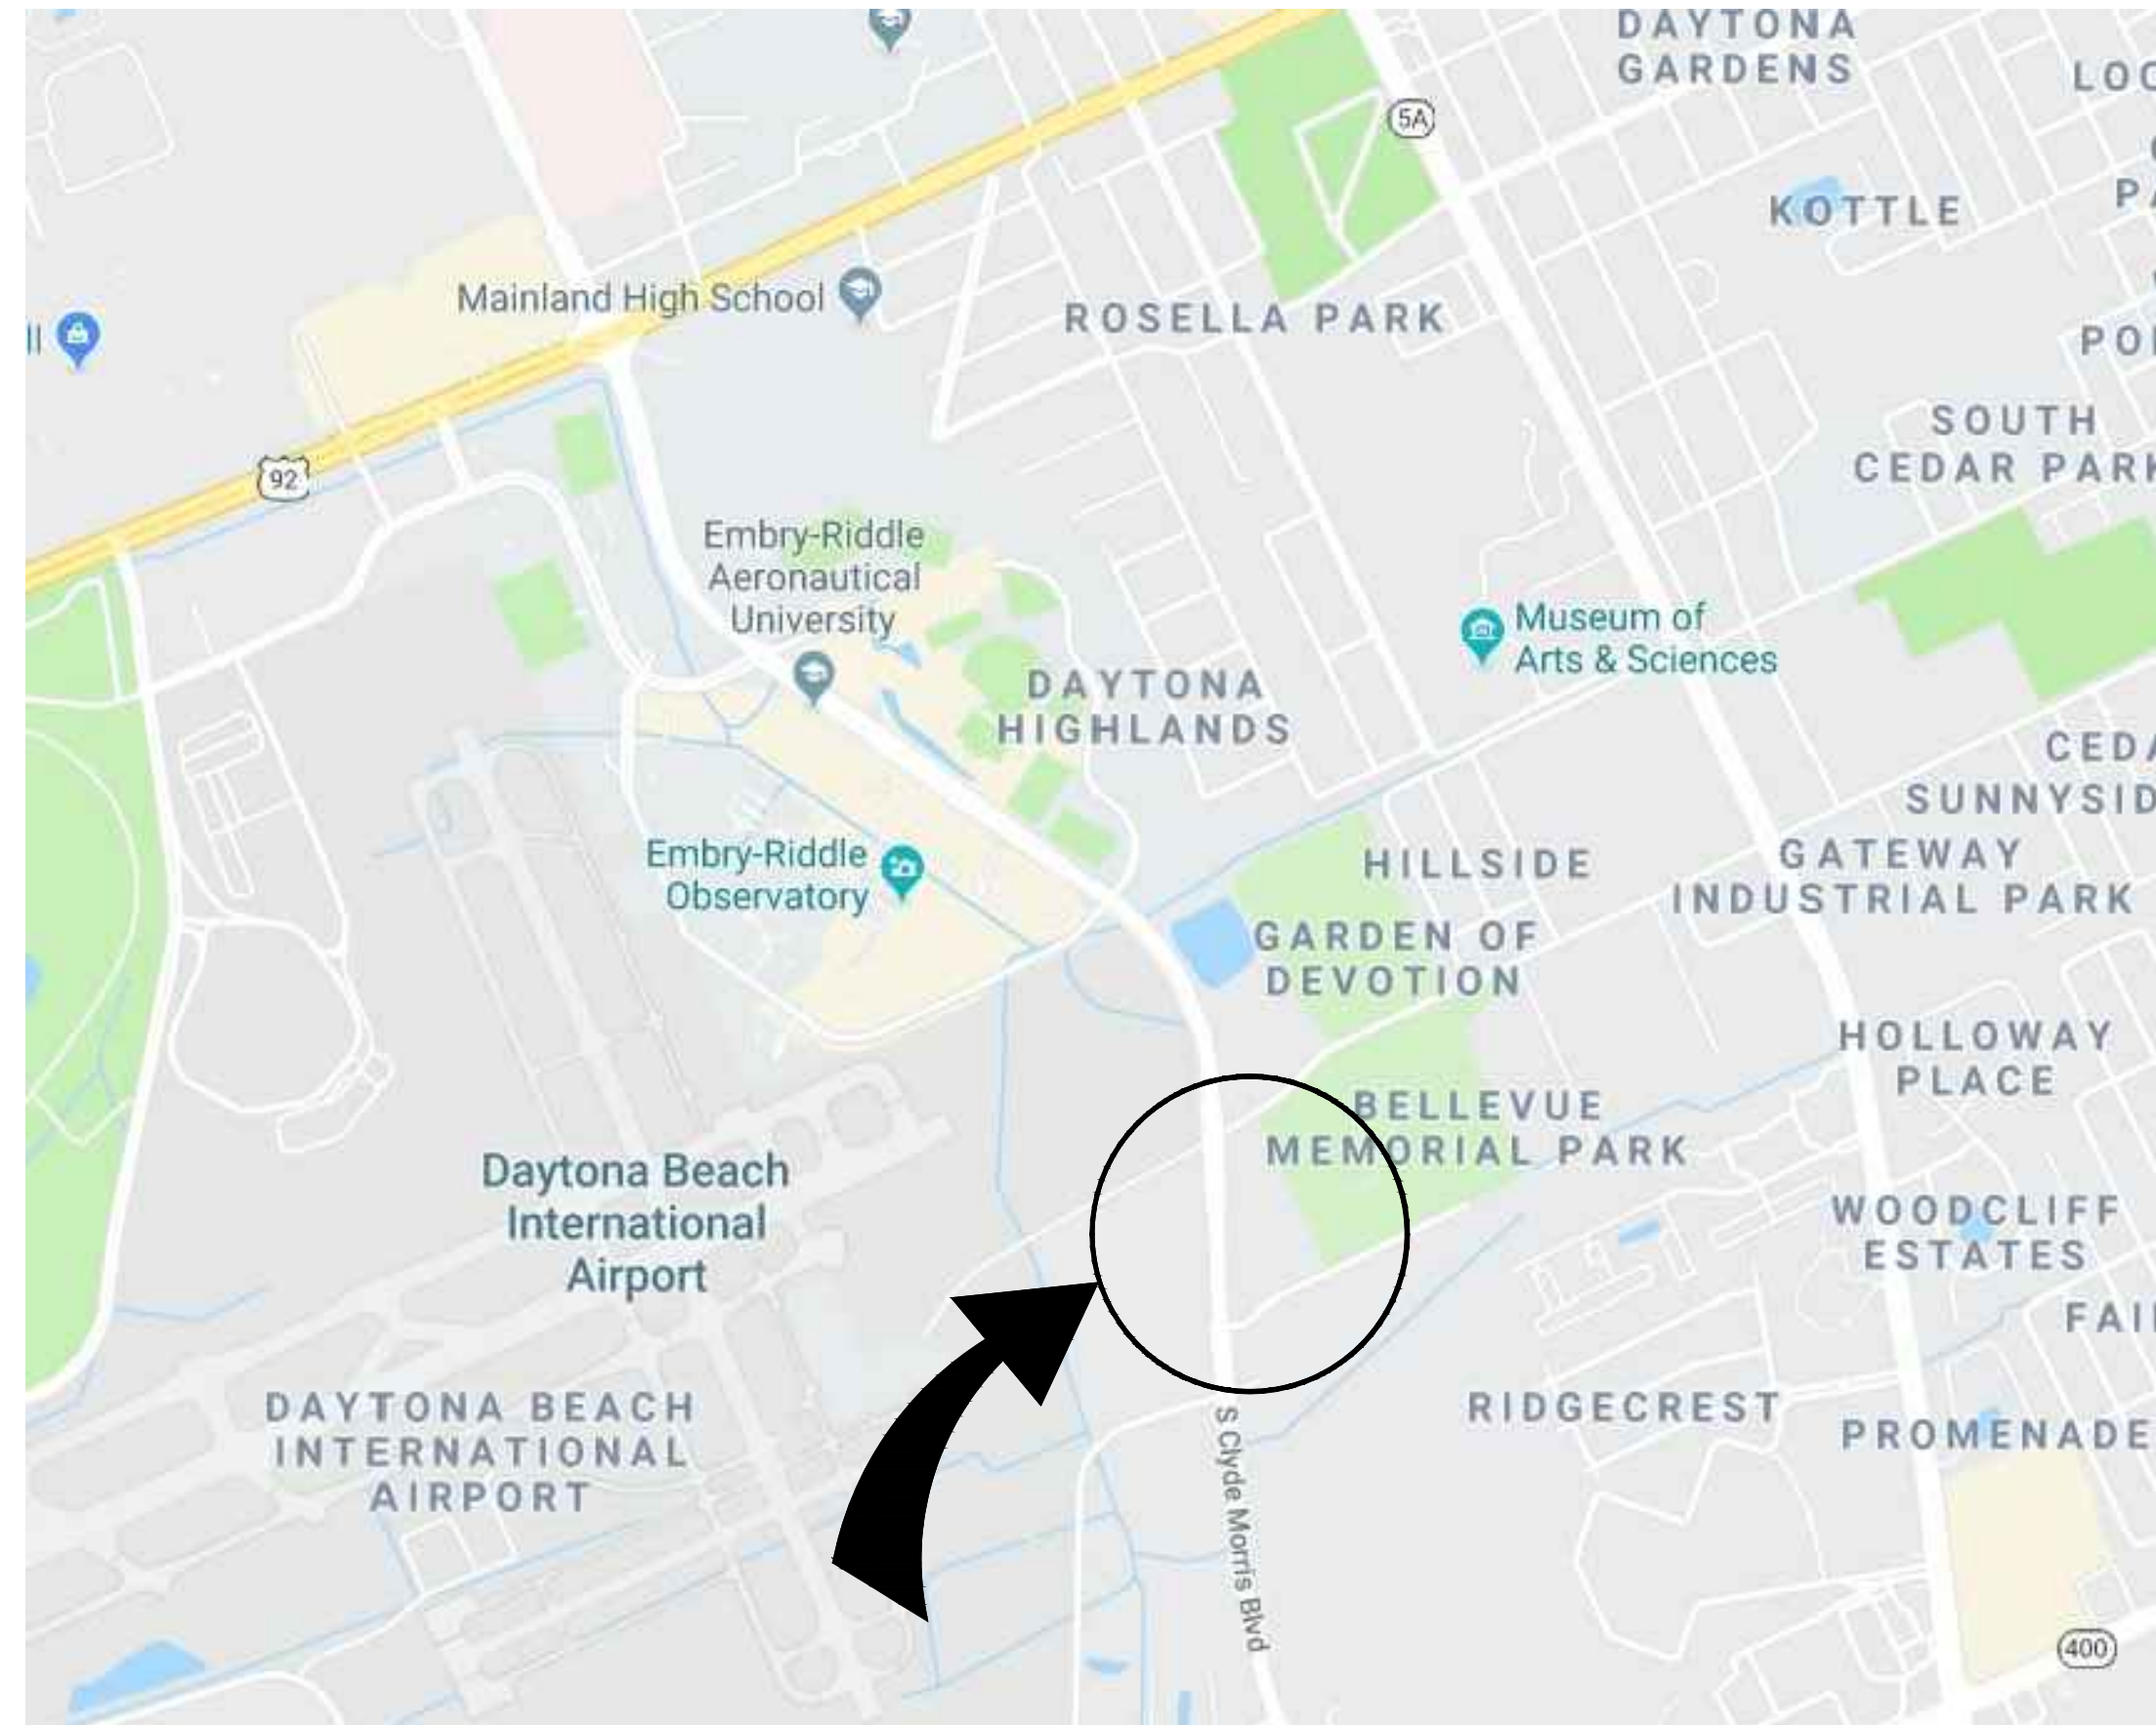

GENERAL PROJECT LOCATION
DAYTONA BEACH, FL 32114-3900



GENERAL PROJECT LOCATION
DAYTONA BEACH, FL 32114-3900

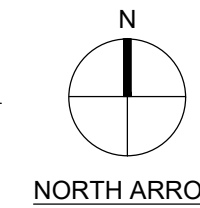

ISSUE HISTORY		
REVISION	ISSUE DATE	DESCRIPTION
	07/12/2019	ISSUE FOR PERMIT
	08/07/2019	ISSUE FOR BID
△	08/21/2019	ADDENDUM 1
△	09/09/2019	ADDENDUM 3

DRAWING LIST		
SHEET	TITLE	ISSUE HISTORY
CVR	COVER SHEET	△ △ △
CIVIL		
CIVIL PLANS - PACKAGE OF 19 SHEETS		
GENERAL		
G0.001	GENERAL INFORMATION & CODE SUMMARY	
G1.101	LIFE SAFETY PLAN	
G2.101	DOOR SCHEDULE, TYPES & DETAILS	
G2.102	DOOR & WINDOW DETAILS	
ARCHITECTURAL		
A0.100	SITE PLAN	
A1.101	FLOOR PLAN	
A1.110	ENLARGED PLANS & DETAILS	
A1.201	ROOF & CLERESTORY PLANS	
A2.101	EXTERIOR ELEVATIONS	△
A3.101	BUILDING SECTIONS	
A4.101	WALL SECTIONS	
A4.102	WALL SECTIONS	
A7.101	FINISH SCHEDULE & PLAN	
A8.101	REFLECTED CEILING PLAN	
A9.101	INTERIOR ELEVATIONS & DETAILS	
STRUCTURAL		
S-100	GENERAL STRUCTURAL NOTES & DETAILS	
S-101	FOUNDATION DETAILS	
S-200	FOUNDATION PLAN	
PLUMBING		
P0.1	LEGEND AND GENERAL NOTES - PLUMBING	
P1.1	SITE PLAN - PLUMBING	
P1.2	FLOOR PLAN - PLUMBING	
P1.3	ENLARGED FLOOR PLAN & RISERS - PLUMBING	
MECHANICAL		
M0.1	LEGEND AND GENERAL NOTES - MECHANICAL	
M0.2	EQUIPMENT SCHEDULES - MECHANICAL	
M1.1	FLOOR PLAN - MECHANICAL	
M5.1	DETAILS - MECHANICAL	
M6.1	CONTROLS - MECHANICAL	
ELECTRICAL		
E0.1	LEGEND AND GENERAL NOTES - ELECTRICAL	△ △
E1.1	SITE PLAN - ELECTRICAL	△ △
E1.2	FLOOR PLAN - POWER & SYSTEMS	△ △
E1.3	REFLECTED CEILING PLAN - ELECTRICAL	△ △
E1.4	SITE PLAN - PHOTOMETRICS	△ △
E5.1	DETAILS - ELECTRICAL	△ △
E5.2	DETAILS - SITE LIGHTING	△ △
E6.1	RISER DIAGRAM AND FEEDER SCHEDULES	△ △
E6.2	FIRE ALARM RISER DIAGRAM AND I/O MATRIX	△ △
E6.3	LIGHTING CONTROL DIAGRAMS	△ △
E7.1	SCHEDULES - ELECTRICAL	△ △

CODES AND STANDARDS	
THESE DOCUMENTS HAVE BEEN PREPARED AND ARE IN COMPLIANCE WITH THE REQUIREMENTS OF THE FOLLOWING CODES AND STANDARDS:	
<ul style="list-style-type: none"> 2017 FLORIDA BUILDING CODE BUILDING 2017 FLORIDA BUILDING CODE RESIDENTIAL 2017 FLORIDA BUILDING CODE EXISTING BUILDING 2017 FLORIDA BUILDING CODE ENERGY CONSERVATION 2017 FLORIDA BUILDING CODE FUEL GAS 2017 FLORIDA BUILDING CODE PLUMBING 2017 FLORIDA BUILDING CODE MECHANICAL 2017 FLORIDA BUILDING CODE TEST PROTOCOLS 2017 FLORIDA ACCESSIBILITY CODE 2014 NATIONAL ELECTRIC CODE (NFPA 70) 2017 FLORIDA FIRE PREVENTION CODE 	

DATE	08/21/2019	09/09/2019		
REVISION	△ ADDENDUM 1	△ ADDENDUM 3		
			DRAWN	CHECKED
EMBRY-RIDDLE AERONAUTICAL UNIVERSITY NEW PRINT SHOP BUILDING				
Date	07/12/2019	Job no.	SOBE 19005	Sheet no.
COVER SHEET				CVR

ADDENDUM 3 - 09/09/2019