


ERAU PRODUCTION BUILDING

EMBRY-RIDDLE AERONAUTICAL UNIVERSITY DAYTONA BEACH, FL CAMPUS

SALAS O'BRIEN
[expect a difference]
3501 Quadrangle Boulevard, Suite 100
Orlando, Florida 32817
(407) 390-0400
CERT. OF AUTH. NO. 6196
■ GARY A. WILKERSON, P.E. 43167
■ KYLE J. CARTER, P.E. 63089
■ JEFF A. KIRKMAN, P.E. 65629
■ ADAM S. LEVINE, P.E. 77010
19035

**HOUSEMAN
ARCHITECTURE**
831 S. SEMORAN BLVD. #204B WINTER PARK, FL 32792
321-872-8446 A0017845
ALL IDEAS, DESIGN, AND DETAILS REPRESENTED BY THIS DRAWING ARE OWNED BY AND THE PROPERTY OF HOUSEMAN ARCHITECTURE, LLC AND NOT BE LOANED, REPRODUCED, COPIED, OR USED FOR ANY OTHER PROJECT WITHOUT THE WRITTEN PERMISSION OF HOUSEMAN ARCHITECTURE, LLC.

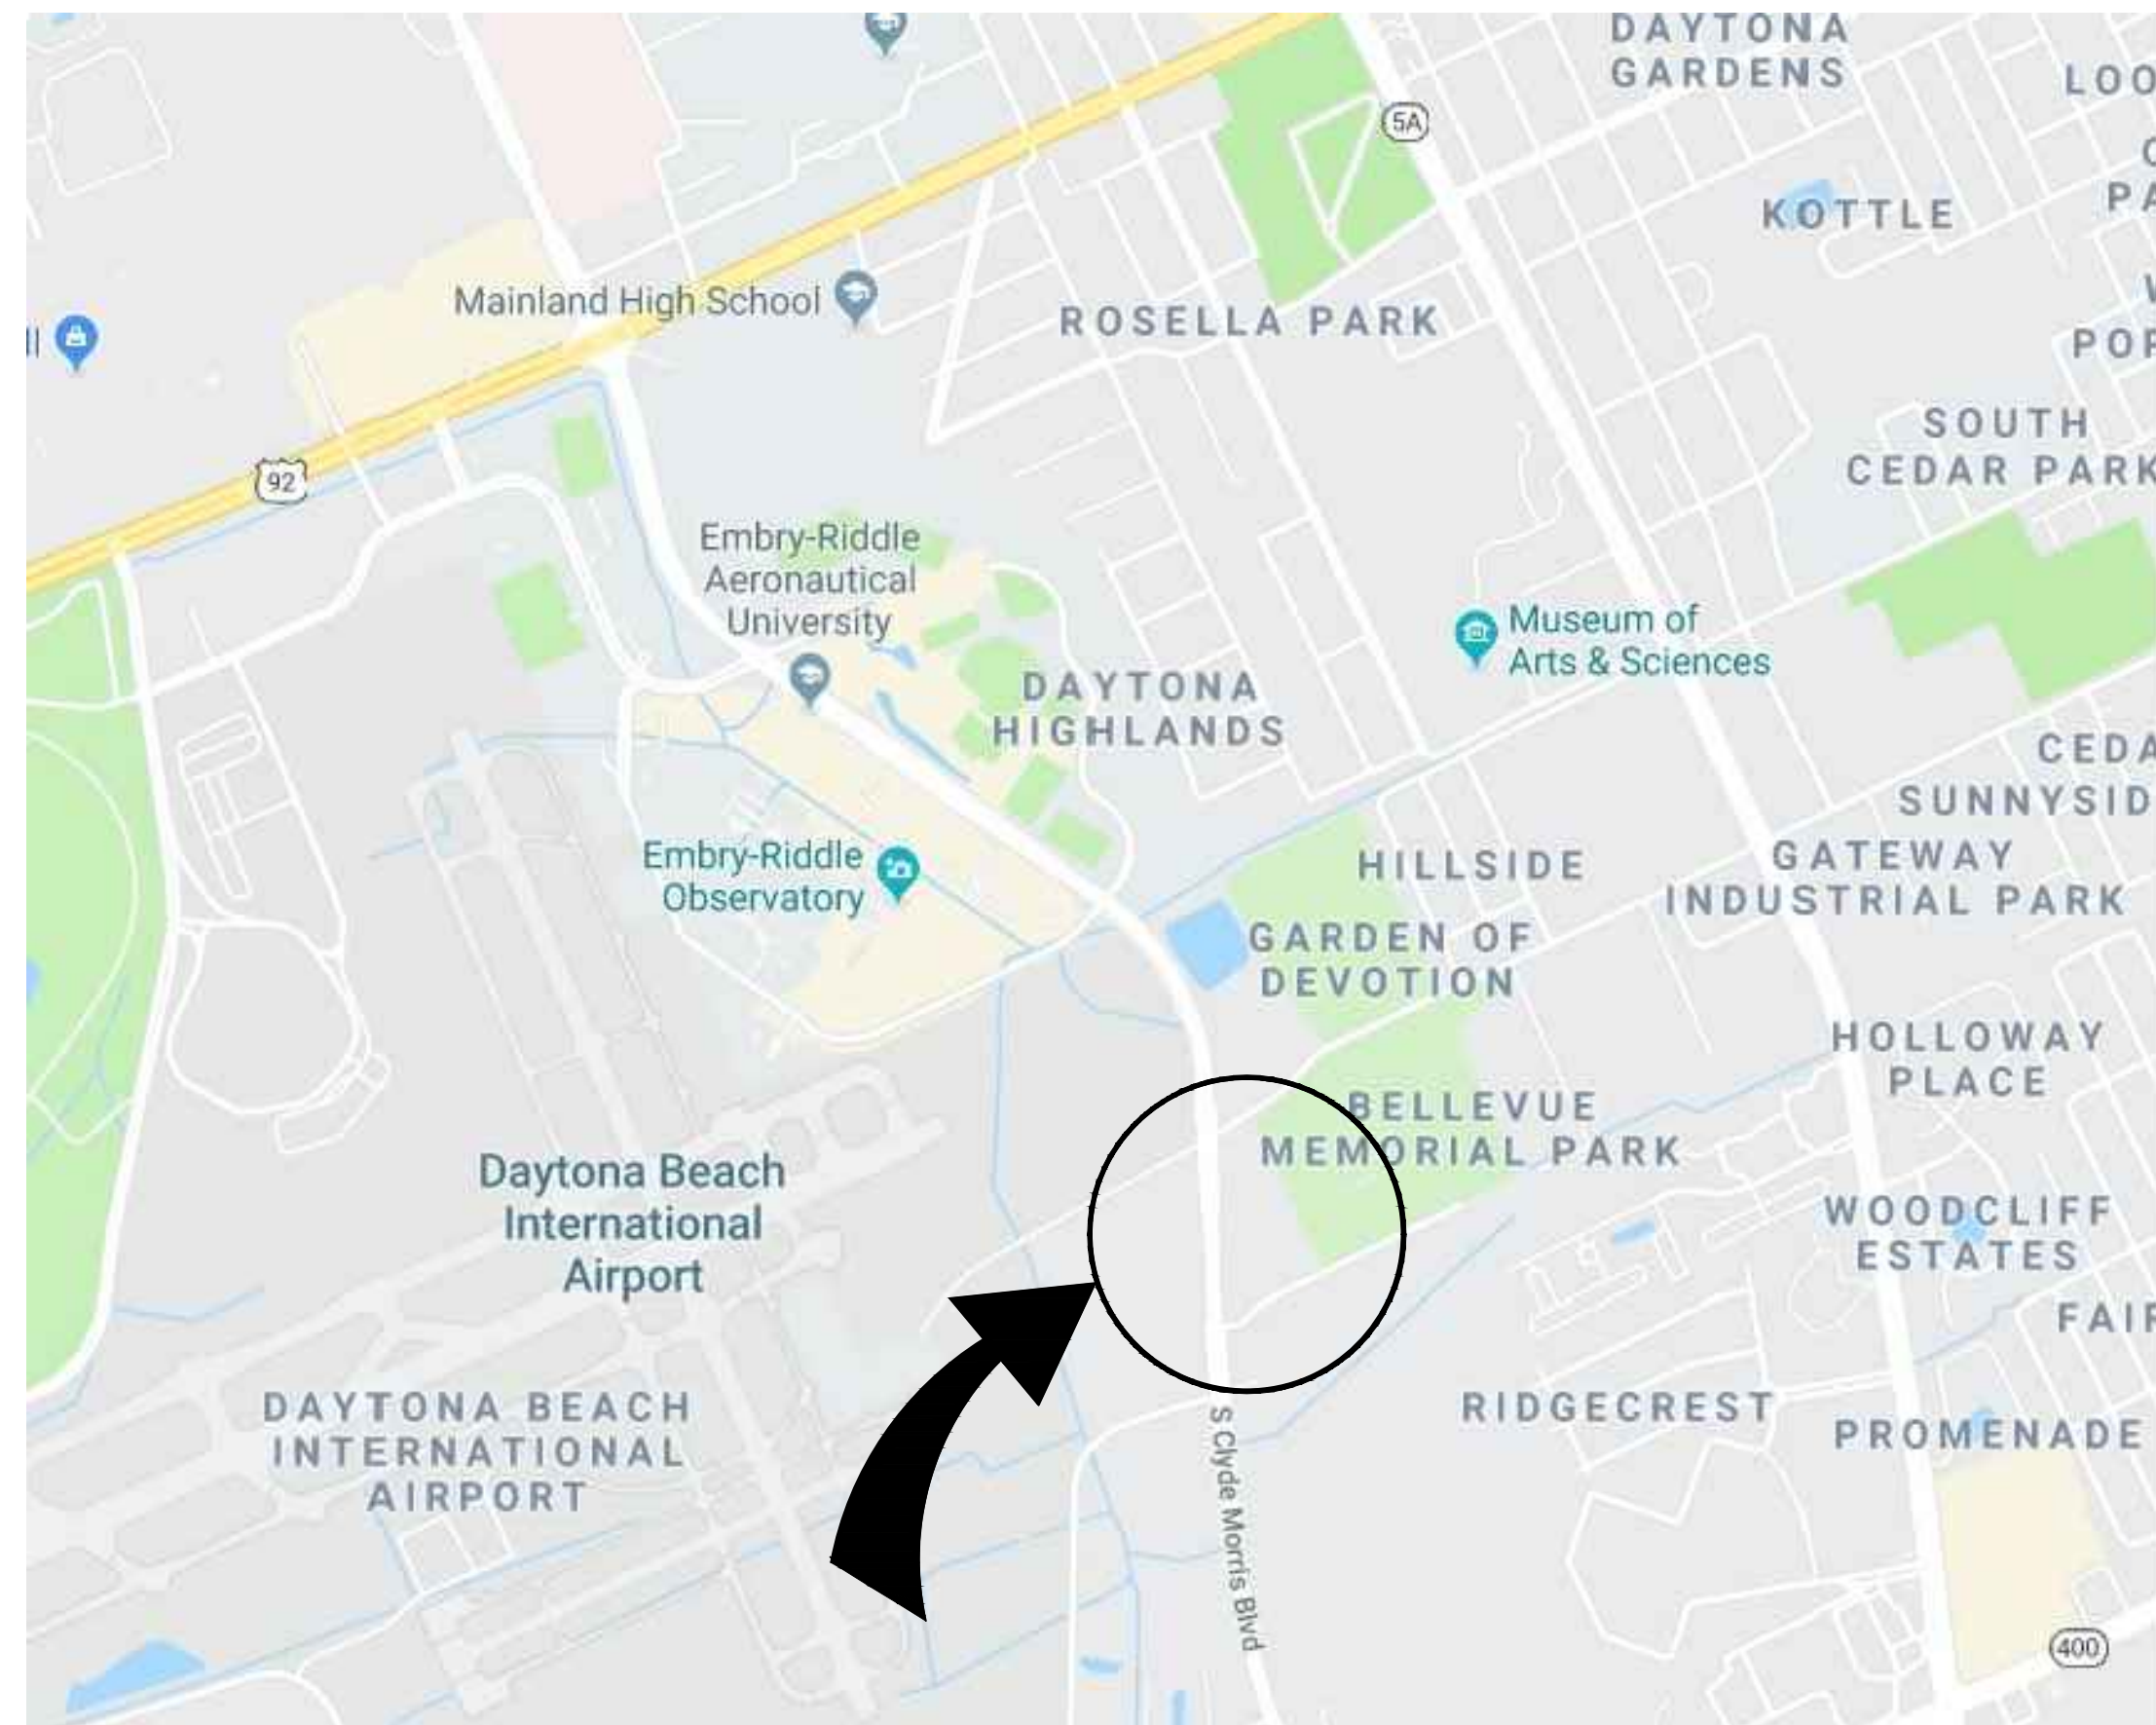

GENERAL PROJECT LOCATION
DAYTONA BEACH, FL 32114-3900



GENERAL PROJECT LOCATION
DAYTONA BEACH, FL 32114-3900



ISSUE HISTORY		
REVISION	ISSUE DATE	DESCRIPTION
	12/20/2019	ISSUE FOR BID
▲	01/03/2020	ADDENDUM # 1
▲	01/15/2020	ADDENDUM # 2

DRAWING LIST		
SHEET	TITLE	REVISION LOG
CVR	COVER SHEET	▲
GENERAL		
G0.001	GENERAL INFORMATION & CODE SUMMARY	
G1.101	LIFE SAFETY PLAN - FIRST FLOOR	
G1.102	LIFE SAFETY PLAN - SECOND FLOOR	
G1.110	UL ASSEMBLIES	
G2.101	DOOR SCHEDULE & DETAILS	▲
G2.102	DOOR SCHEDULE & DETAILS	▲
ARCHITECTURAL		
A0.100	ARCHITECTURAL SITE PLAN	
A1.101	FLOOR PLAN - FIRST FLOOR	▲
A1.102	FLOOR PLAN - SECOND FLOOR	
A1.110	ENLARGED PLANS & DETAILS	▲
A1.201	ROOF PLAN & DETAILS	
A1.202	ROOF DETAILS	▲
A2.101	EXTERIOR ELEVATIONS	
A2.201	GLAZING ELEVATIONS	▲
A3.101	BUILDING SECTIONS	▲
A4.101	WALL SECTIONS	▲
A4.102	WALL SECTIONS	▲
A5.101	STAIR PLANS & DETAILS	▲
A5.102	STAIR PLANS & DETAILS	▲
A6.101	ELEVATOR PLANS, SECTION & DETAILS	▲
A7.101	FINISH PLAN - FIRST FLOOR	▲
A7.102	FINISH PLAN - SECOND FLOOR	▲
A8.101	REFLECTED CEILING PLAN - FIRST FLOOR	▲
A8.102	REFLECTED CEILING PLAN - SECOND FLOOR	▲
A9.101	INTERIOR ELEVATION & DETAILS	
PLUMBING		
P1.001	LEGEND, NOTES AND SCHEDULES - PLUMBING	
P1.101	FLOOR PLAN - FIRST FLOOR - PLUMBING	
P1.102	FLOOR PLAN - SECOND FLOOR - PLUMBING	
P1.401	RISER DIAGRAMS - PLUMBING	
MECHANICAL		
M1.001	LEGEND AND GENERAL NOTES - MECHANICAL	
M1.101	FLOOR PLAN - FIRST FLOOR - MECHANICAL	
M1.102	FLOOR PLAN - SECOND FLOOR - MECHANICAL	
M1.501	DETAILS - MECHANICAL	
M1.502	DETAILS - MECHANICAL	
M1.503	DETAILS - MECHANICAL	
M1.601	SCHEDULES - MECHANICAL	▲
M1.701	CONTROLS - MECHANICAL	▲
ELECTRICAL		
E1.001	SYMBOL LEGEND, LIGHT FIXT. SCHED. & GEN NOTES - ELECTRICAL	
E1.100	SITE PLAN - ELECTRICAL	▲
E1.101	FLOOR PLAN - FIRST FLOOR - PWR & SYSTEMS	▲
E1.102	FLOOR PLAN - SECOND FLOOR - PWR & SYSTEMS	▲
E1.201	FLOOR PLAN - FIRST FLOOR - LIGHTING	▲
E1.202	FLOOR PLAN - SECOND FLOOR - LIGHTING	▲
E1.401	RISER DIAGRAM AND SCHEDULES - ELEC.	
E1.402	RISER DIAGRAM AND I/O MATRIX - FIRE ALARM	
E1.403	LIGHTING CONTROL DIAGRAMS	
E1.501	DETAILS - ELECTRICAL	
E1.601	SCHEDULES - ELECTRICAL	▲
E1.602	SCHEDULES - ELECTRICAL	▲

CODES AND STANDARDS	
THESE DOCUMENTS HAVE BEEN PREPARED AND ARE IN COMPLIANCE WITH THE REQUIREMENTS OF THE FOLLOWING CODES AND STANDARDS:	
<ul style="list-style-type: none"> • 2017 FLORIDA BUILDING CODE BUILDING • 2017 FLORIDA BUILDING CODE RESIDENTIAL • 2017 FLORIDA BUILDING CODE EXISTING BUILDING • 2017 FLORIDA BUILDING CODE ENERGY CONSERVATION • 2017 FLORIDA BUILDING CODE FUEL GAS • 2017 FLORIDA BUILDING CODE PLUMBING • 2017 FLORIDA BUILDING CODE MECHANICAL • 2017 FLORIDA BUILDING CODE TEST PROTOCOLS • 2017 FLORIDA ACCESSIBILITY CODE • 2014 NATIONAL ELECTRIC CODE (NFPA 70) • 2017 FLORIDA FIRE PREVENTION CODE 	

ADDENDUM 2 - 01/15/2020

REVISION DATE 01/03/2020 01/15/2020
 ADDENDUM 1 ADDENDUM 2
 DRAWN CHECKED
ERAU PRODUCTION BUILDING
 EMBRY-RIDDLE AERONAUTICAL UNIVERSITY, DAYTONA BEACH, FLORIDA
 12/20/2019 2019-5743
 CVR